




1. METEOROLOGICAL INSTRUMENT POWER SUPPLY SHALL BE CONNECTED TO ANE-PD PANELBOARD AT EQUIPMENT ROOM OF POWER PLANT BUILDING. FOR REFERENCE DRAWING REFER TO PURCHASE / INSTALLATION OF PAPI 04/ SYSTEM AND OTHER WORKS. AT BUKIDNON AIRPORT PROJECT SHEET NO. AFL 01 THRU 03.
2. FOR REFERENCE DRAWING FOR UNDERGROUND CABLE DUCTING LAYOUT REFER TO PURCHASE / INSTALLATION OF PAPI 04/ SYSTEM & OTHER WORKS AT BUKIDNON AIRPORT PROJECT SHEET NO. AFL 04, 05 & 08.

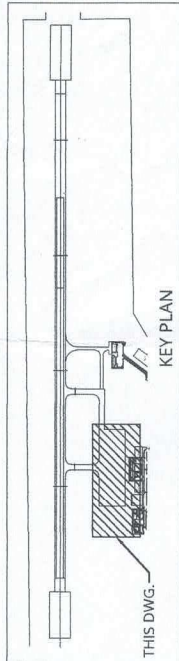

KEY PLAN

THIS DWG. -

FOR CONT. SEE DWG. 2/3

MATCHLINE A-A






8

160

EMH-3

MATCHLINE B-B
FOR CONT. SEE DWG. 3/3

APRON

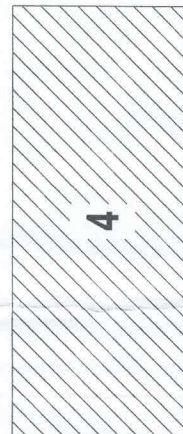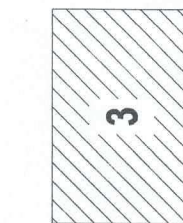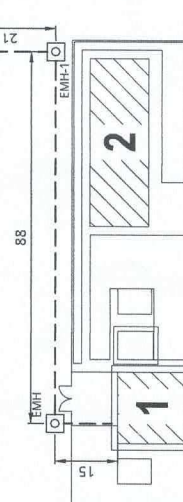

LEGEND:

- ELECTRICAL MAINTENANCE HOLE (BY OTHERS)
- 1 - 3C 8AWG XLPE 600V
- POWER PLANT BUILDING
- CONTROL TOWER BUILDING
- CARGO BUILDING
- PASSENGER TERMINAL BUILDING



SCALE BAR 1:1200



RWY 04 SIDE WEATHER SENSOR CABLE LAYOUT

$$\frac{1}{1:1200}$$

CIVIL AVIATION UNIVERSITY OF THE PHILIPPINES		PREPARED BY:	CHECKED BY:	REVIEWED BY:	SUBMITTED BY:	RECOMMENDING APPROVAL:	APPROVED BY:	CONCURRED BY:	SHEET NO.:
 PROVISION OF ANF EQUIPMENT (MET DUAL SITE) FOR BUKIDNON AIRPORT	 WILFREDO TABITAN ANPE/ANPPDD	 ALBINIO L. SOMIDO CNSO IV, ANPPDD	 JOERNANDO S. CEREBRANCA Division Chief, ANPPDD	 JOSEPH M. SOGUI Acting Department Manager, ANCSMD	 LEANDRO R. VARQUEZ Department Manager III, ANPPDD	 GARY M. JADRE Acting Chief, Air Navigation Service	 LTGEN RAUL D. ROSARIO (RP RET) Director General, CAA/AT	CAPT. JIM C. SYDIONGCO Undersecretary Aviation Airports, DOT	1/3 DATE: 10 MAR 2015

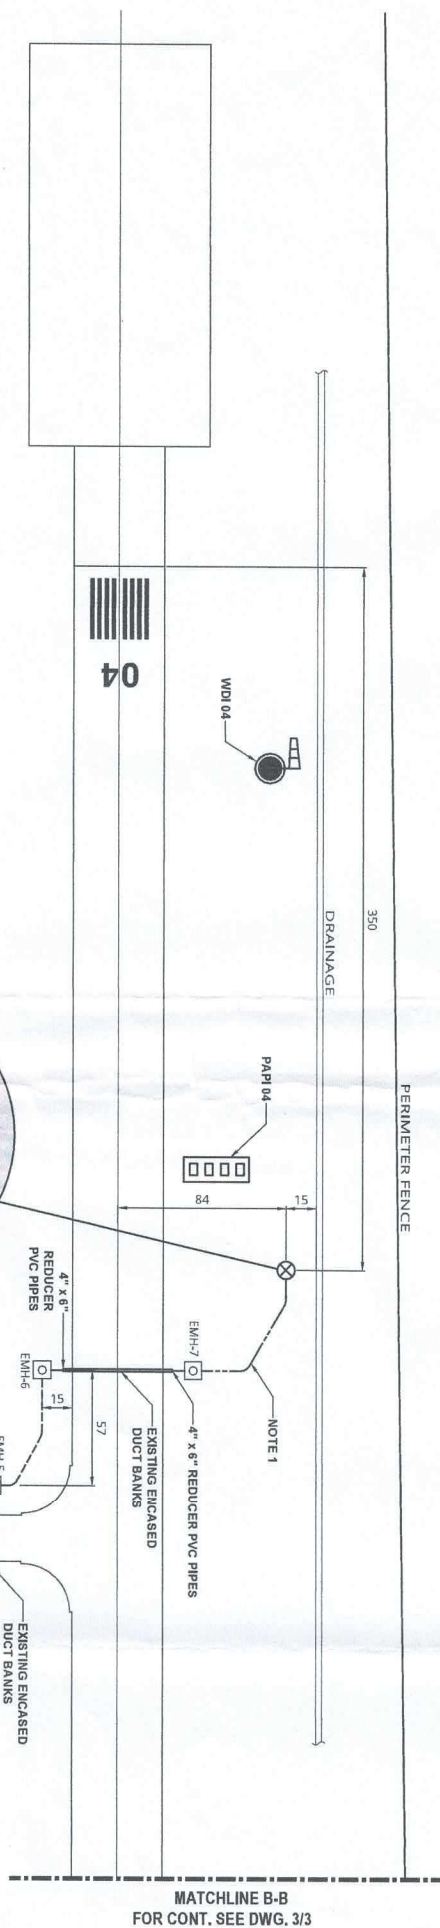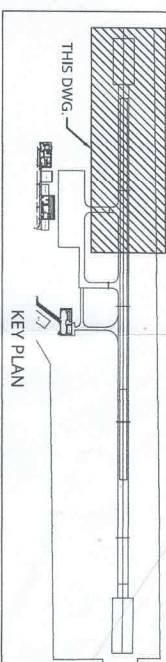

LEGEND:

- ELECTRICAL MAINTENANCE HOLE (EMH) (BY OTHERS)
- 1 - 3C BAWG XLPE 600V
-

NOTES:

- 2\"/>

RWY 04 SIDE WEATHER SENSOR CABLE LAYOUT
SCALE 1:2500



Civil Aviation Authority of the Philippines	TITLE:	DRAWN BY:	PREPARED BY:	CHECKED BY:	REVIEWED BY:	SUBMITTED BY:	RECOMMENDING APPROVAL:	APPROVED BY:	CONCURRED BY:	SHEET NO.:
 AIR NAVIGATION SERVICE	PROVISION OF ANF EQUIPMENT (MET DUAL SITE) FOR BUKIDNON AIRPORT	WILLIAM D. LABITAN AEPF I, ANPPD	ALBINO L. SOMIDO CNSSO IV, ANPPD	JOSEPH O. BERNALDO Division Chief III, ANPPD	JOSUE R. STUBI Acting Department Manager, ANPPD	LEANDRO R. VARGUEZ Department Manager III, ANPPD	GARY M. JADIE Acting Chief, Air Navigation Service	LIGERILLO DEL ROSARIO Director General, CAAP	CAPT. JIM C. SYDIONGCO Undersecretary Aviation Airports, DOTr	2/3 DATE: 10 MAR 2025

